


Legend (See Sheet EX1.0 for existing conditions Legend)

- Proposed blue phone
- New light pole and base
- Inlet protection around catch basin
- Preconstruction Excavation
- Finish Grade Spot Grade Elevation
- Finish Grade Direction of Flow
- New Finish Grade Contour
- New Gas Line/Valve
- New Sewer Line/Manhole
- New Sewer Forcemain
- New Storm Line/Manhole/Basin
- New Underdrain
- New Footing Drain - See Structural
- New Roof Drain
- New Water Line/Hydrant/Valve/Shutoff
- New PBX Line/manhole
- New Concrete/Granite Curb
- New pavement and subbase
- New Concrete Walk
- New Crushed Stone
- New Bioretention Soils & Plantings

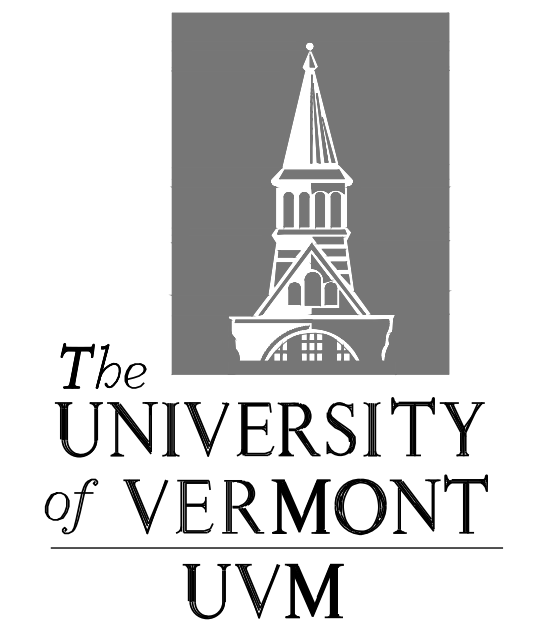

University of Vermont
 Physical Plant Department
 284 EAST AVENUE
 BURLINGTON, VERMONT 05405
 Project Manager: Scott Goodwin

CIVIL ENGINEER
KREBS & LANSING
 CONSULTING ENGINEERS
 184 Main Street, Suite 201 P. (802) 878-0375
 Colchester, Vermont 05446 www.krebsandlansing.com



Project:
 University of Vermont
 Jeffords East
 Lower Lot

Project No. 19249
 Scale 1"=20'
 Drawn by DMR
 Checked by
 Date 9/26/2019

Revisions	No.	Date

Drawing Title
 Site Plan

Drawing No.
C-1.1